


KEY *NOT ALL ITEMS ON THIS KEY FEATURE IN THIS DRAWING

SHARED USE PATH	SHEFFIELD STANDS (160 SPACES)	LOCKABLE PUBLIC TRANSPORT BARRIER
ASPHALT CARRIAGEWAY	CHARGING BAYS (108 SPACES)	ELECTRONICALLY CONTROLLED GATES
FOOTWAYS	BUILDING LOCATION	CULVERT HEADWALL
STORAGE PONDS	COVERED WAITING AREAS	EARTHWORKS- CUT
SWALE BRIDGE	SOLAR PANELS	EARTHWORKS- FILL
DISABLED BAYS (108 SPACES)	PERMEABLE BLOCK PAVED PARKING BAYS (2150 SPACES)	ILLUMINATED BOLLARD
VELO LOCKERS (150 LOCKERS)	PEDESTRIAN GUARDRAIL	TH- GALVANISED STEEL LIGHTING COLUMN
PROPOSED HEIGHT RESTRICTION BARRIER	BLOCK PAVED FOOTWAY	HIGHWAYS LIGHTING COLUMNS
M STANDS FOR LARGER CYCLES (16 SPACES)	DETERRENT PAVING	EXISTING LIGHTING COLUMNS TO REMAIN
TACTILE PAVING	TRAFFIC LIGHTS	DRAINAGE SWALE

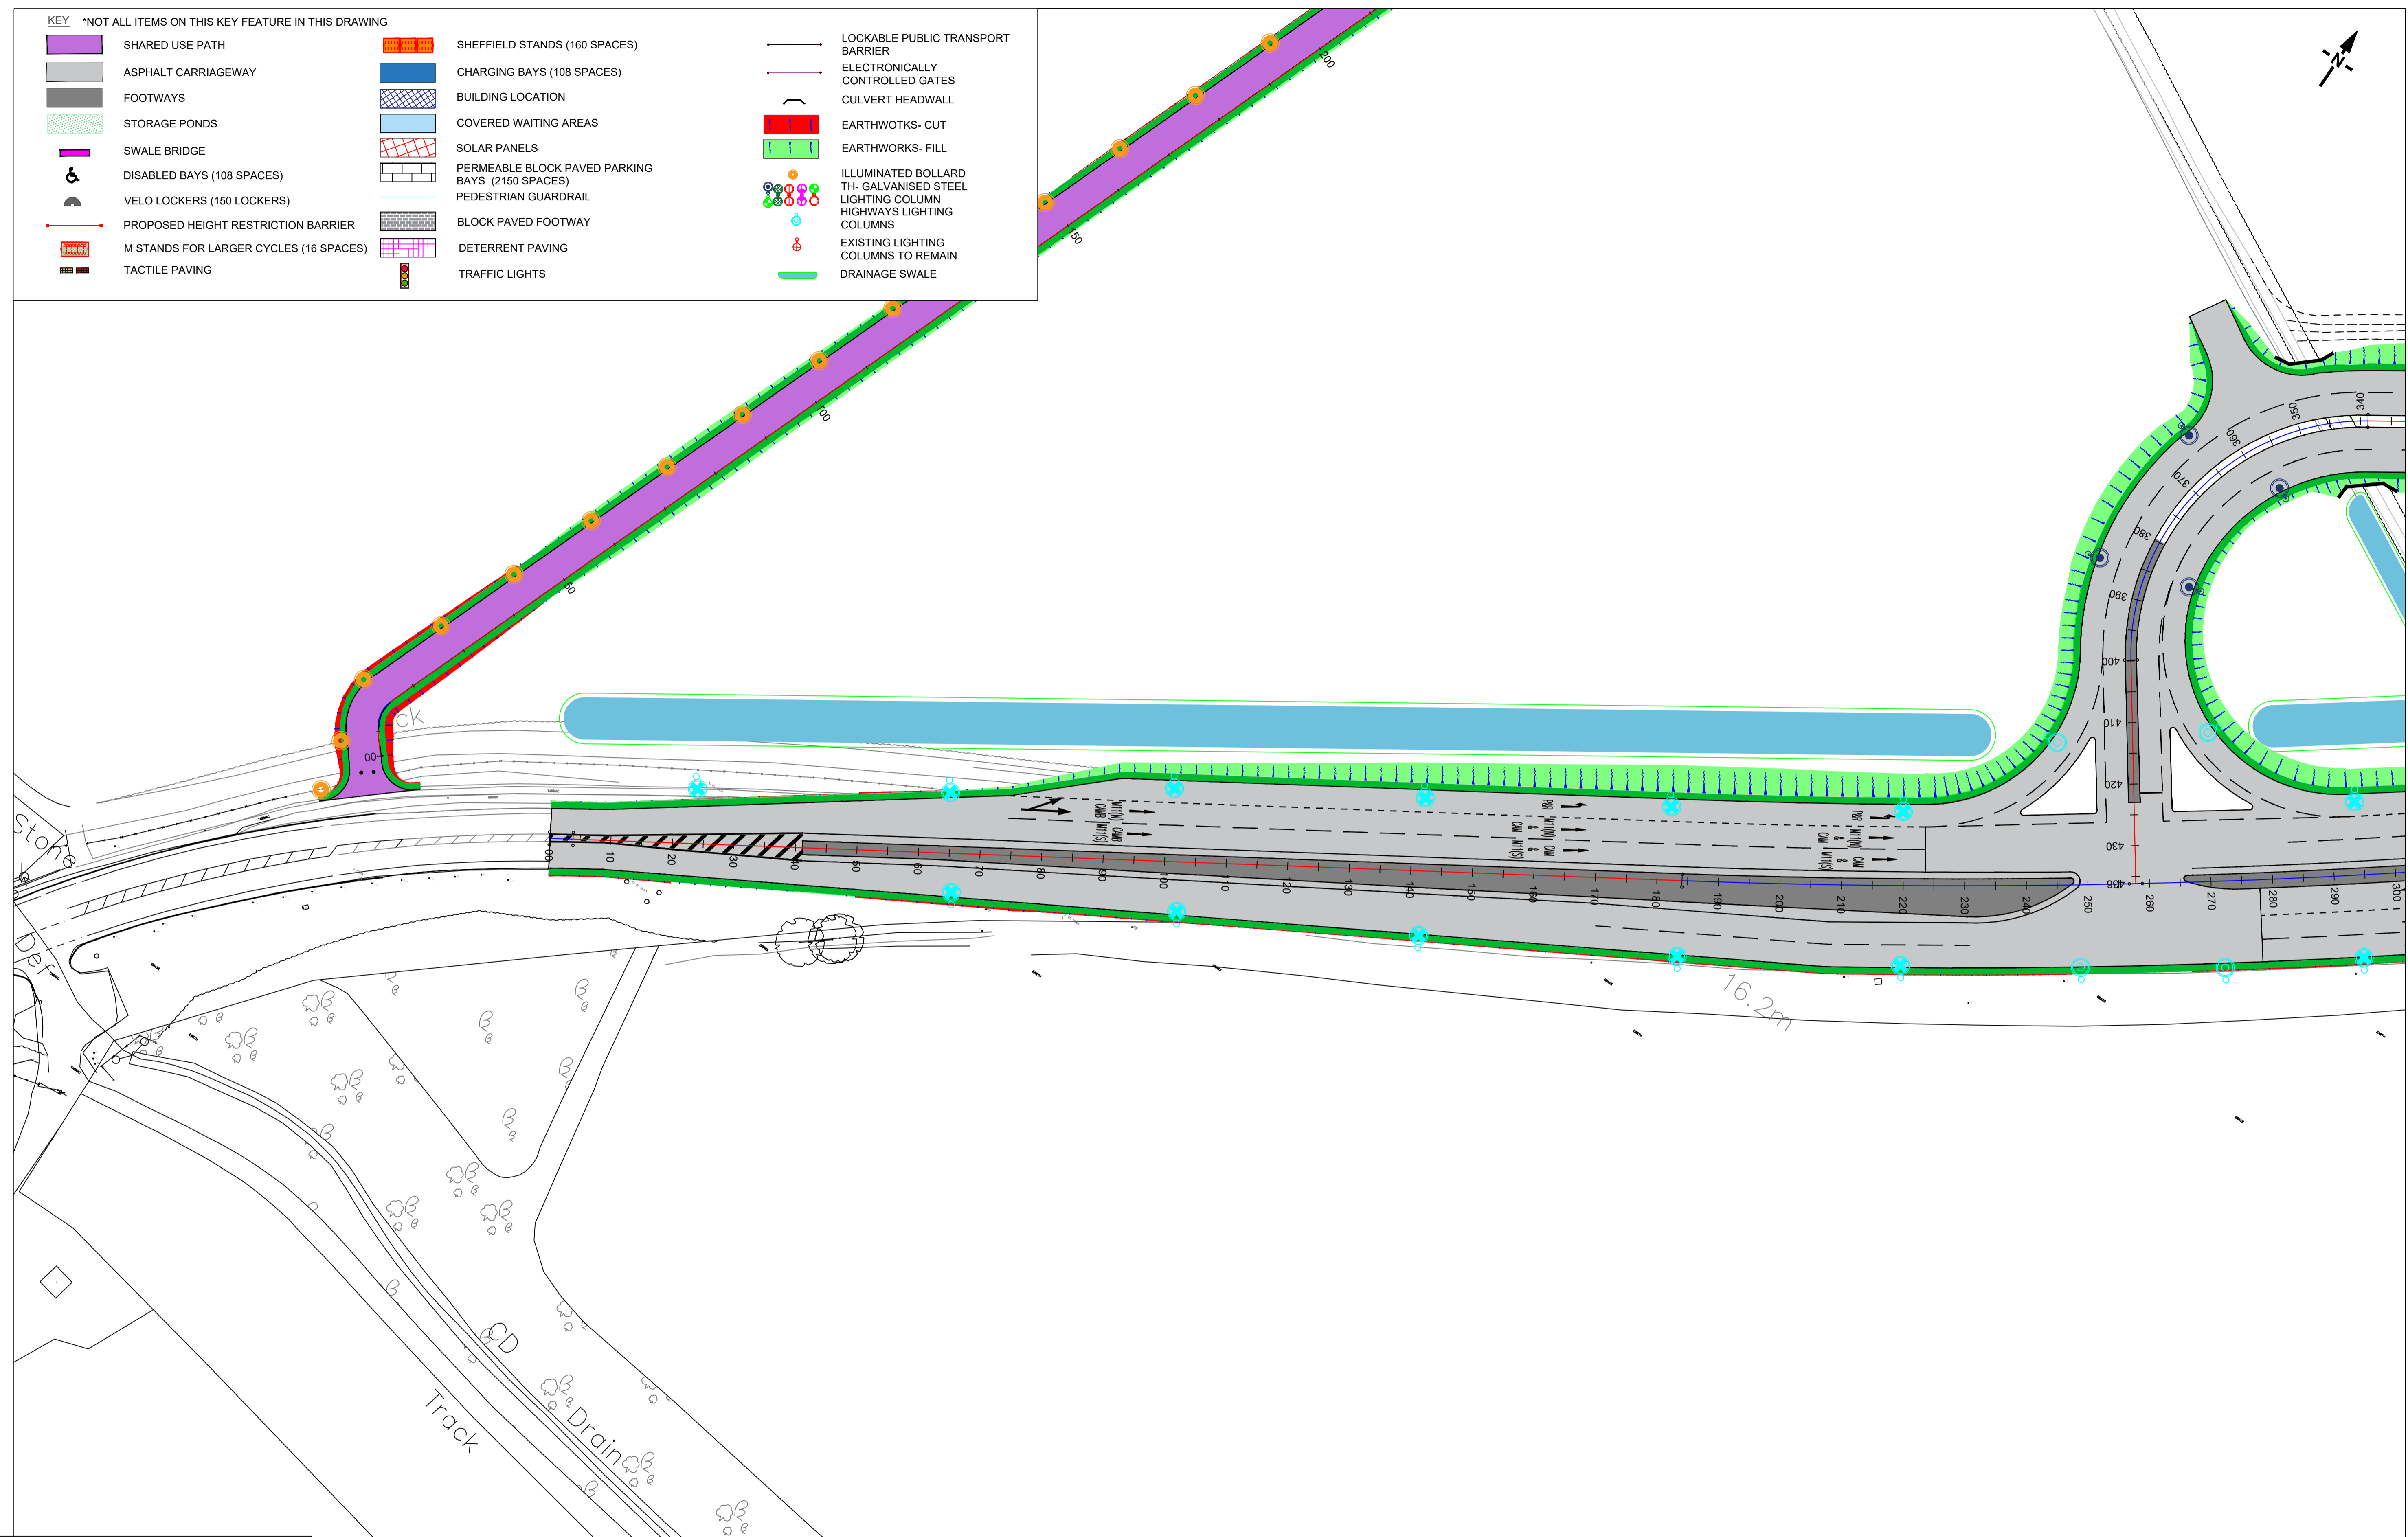

NOTES

- FOR HIGHWAYS CROSS SECTIONS PLEASE REFER TO DRAWINGS H19532-SKA-HGN-ZZ-DR-CH-0710, 711, 713, 715, 716, 717, 718, 719, 721 & 740.
- FOR LIGHTING LAYOUT DETAILS PLEASE REFER TO 1300 SERIES DRAWINGS.
- FOR TRAVEL HUB DRAINAGE DETAILS PLEASE REFER TO 0500 & 0600 SERIES DRAWINGS.
- FOR HIGHWAYS DRAINAGE DETAILS PLEASE REFER TO J&P DRAWINGS.

SAFETY, HEALTH AND ENVIRONMENTAL INFORMATION

CONSTRUCTION	(ENTER 'NONE' IF APPLICABLE)
MAINTENANCE/CLEANING	(ENTER 'NONE' IF APPLICABLE)
USE	(ENTER 'NONE' IF APPLICABLE)
DECOMMISSIONING/DEMOLITION	(ENTER 'NONE' IF APPLICABLE)

Rev	Description	By	Date	Chk'd	Auth	Stat	Purpose of Issue	Date	Auth
P01	ISSUED FOR PLANNING		04.06.20	JRM	AH	S4	SUITABLE FOR STAGE APPROVAL	06/20	AH



Cambridgeshire Highways
 Unit 1A, Vantage House
 Washingley Road
 Huntingdon
 PE29 6SR
 Tel: (01223) 785165
 cambridgeshirehighways@skanska.co.uk

CAMBRIDGE SOUTH WEST TRAVEL HUB

HIGHWAYS GA SHEET 2 OF 8

Original Scale	Designed/Drawn	Checked	Authorised
1:500	ST	JRM	AH
Date	Date	Date	Date
04.06.20	04.06.20	04.06.20	04.06.20

Drawing Number: H19532-SKA-HGN-ZZ-DR-CH-0760-S4
 Rev: P01